





Do not scale from this drawing.  
 Verify dimensions by site measurement.  
 Read this drawing in conjunction with the latest architectural and structural drawings.  
 This drawing is based on the following information:-


The information shown upon this drawing regarding existing services has been based upon details provided by either the utility supply authorities or survey companies. Hilson Moran Partnership Ltd. do not accept any responsibility for the correctness or accuracy of this information and advise that any party make their own enquiries prior to its use.

**Notes**

- Connections to buildings are indicative only.

**Legend**

-  Existing Gas (Intermediate Pressure).
-  Existing Gas (Low Pressure).
-  Proposed New Gas (Low Pressure).
-  Proposed New Gas (Intermediate Pressure).

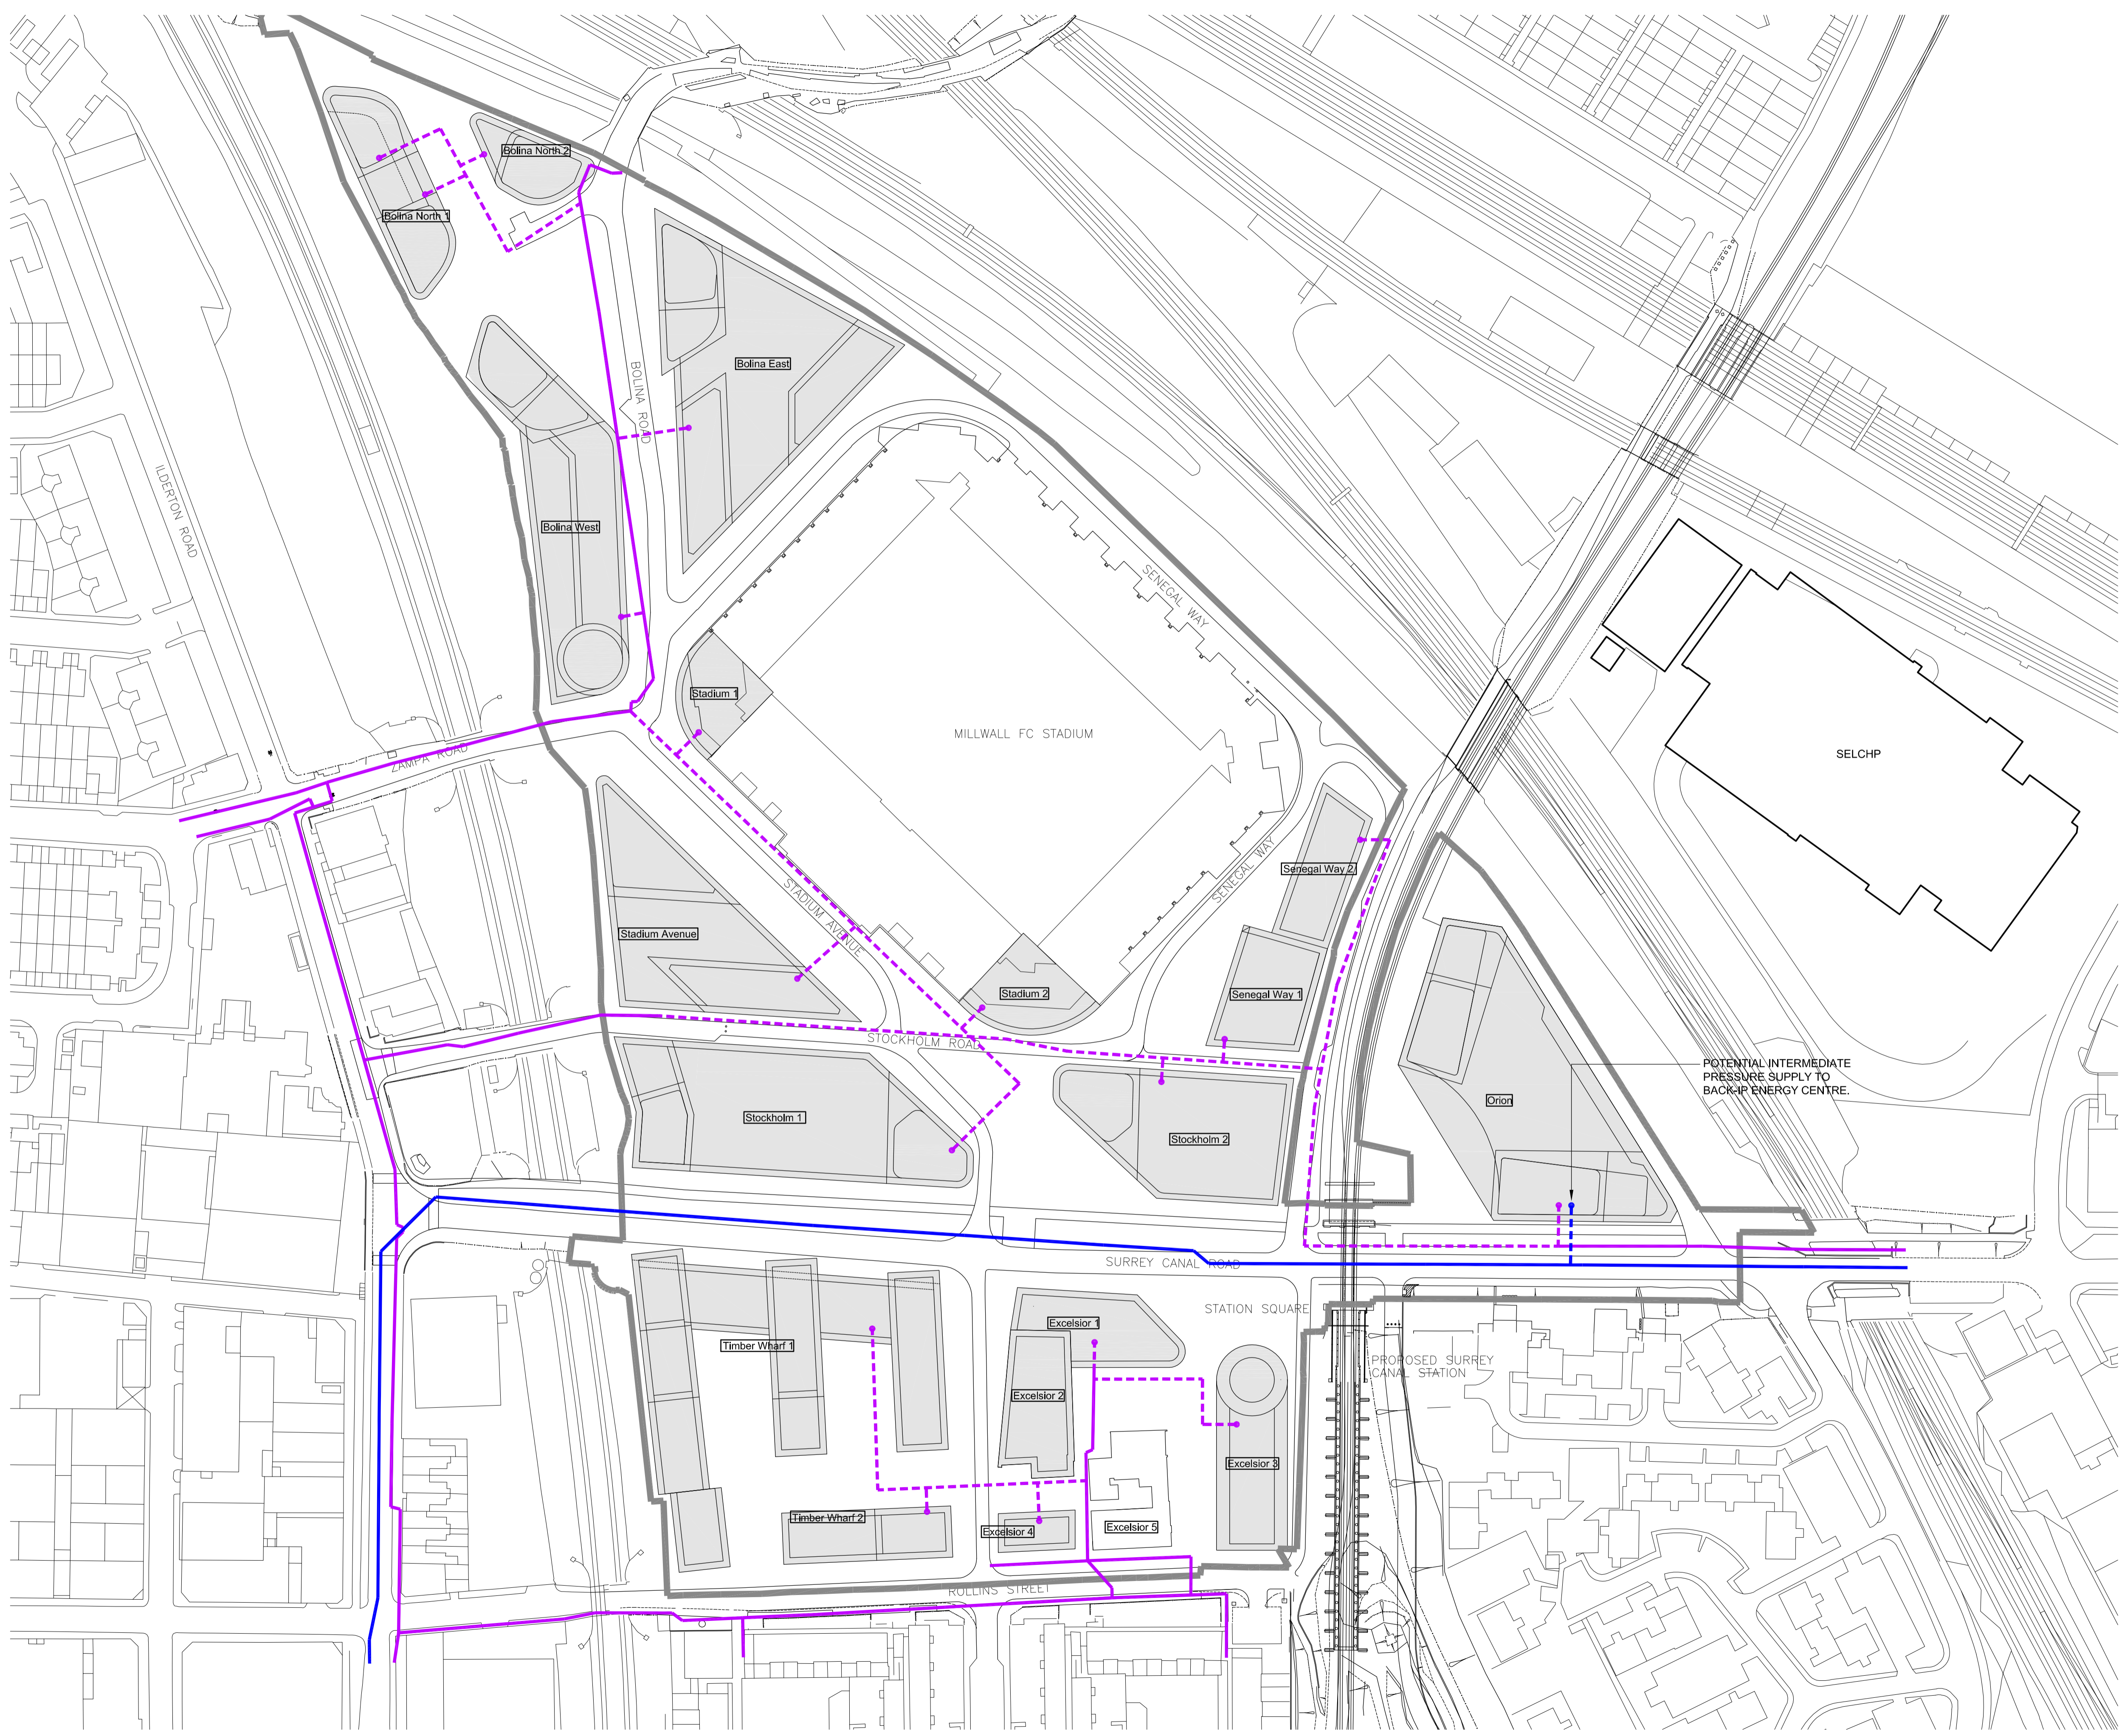

**FOR INFORMATION ONLY**

Revision	Date	Description	Initials	Checked
01	10.12.10	Issued for Information.	CJA	KWH
00	24.11.10	Issued for Information.	CJA	KWH



HILSON MORAN • CONSULTING ENGINEERS

Farnborough: T: + 44(0) 1252 550 500 F: + 44(0) 1252 550 501  
 London: T: + 44(0) 20 7940 8888 F: + 44(0) 20 7940 8801  
 Manchester: T: + 44(0) 161 876 4890 F: + 44(0) 161 877 4989

Architect  
**SEW**  
 1 Compton Courtyard  
 40 Compton Street  
 London EC1V 0AP  
 Client/Project

Renewal  
 Surrey Canal

Title  
**Proposed Site Plan**  
**Proposed Gas Distribution**

Drawn	Checked	Approved
CJA	KWH	-

Date	Sheet Size	Scale
October 2010	A0	1:1000

HMP Drawing Number	File Ref:	Revision
8450/Study/4100	8450-ST-4100-02.dwg	01