

Do not scale from this drawing.
 Verify dimensions by site measurement.
 Read this drawing in conjunction with the latest architectural and structural drawings.
 This drawing is based on the following information:-


The information shown upon this drawing regarding existing services has been based upon details provided by either the utility supply authorities or survey companies. Hilson Moran Partnership Ltd. do not accept any responsibility for the correctness or accuracy of this information and advise that any party make their own enquiries prior to its use.

Notes

- Proposed connections to buildings are indicative only.

Legend

- Existing Water Main.
- Existing Water Trunk Main.
- - - New Water Mains.
- Site Boundary.

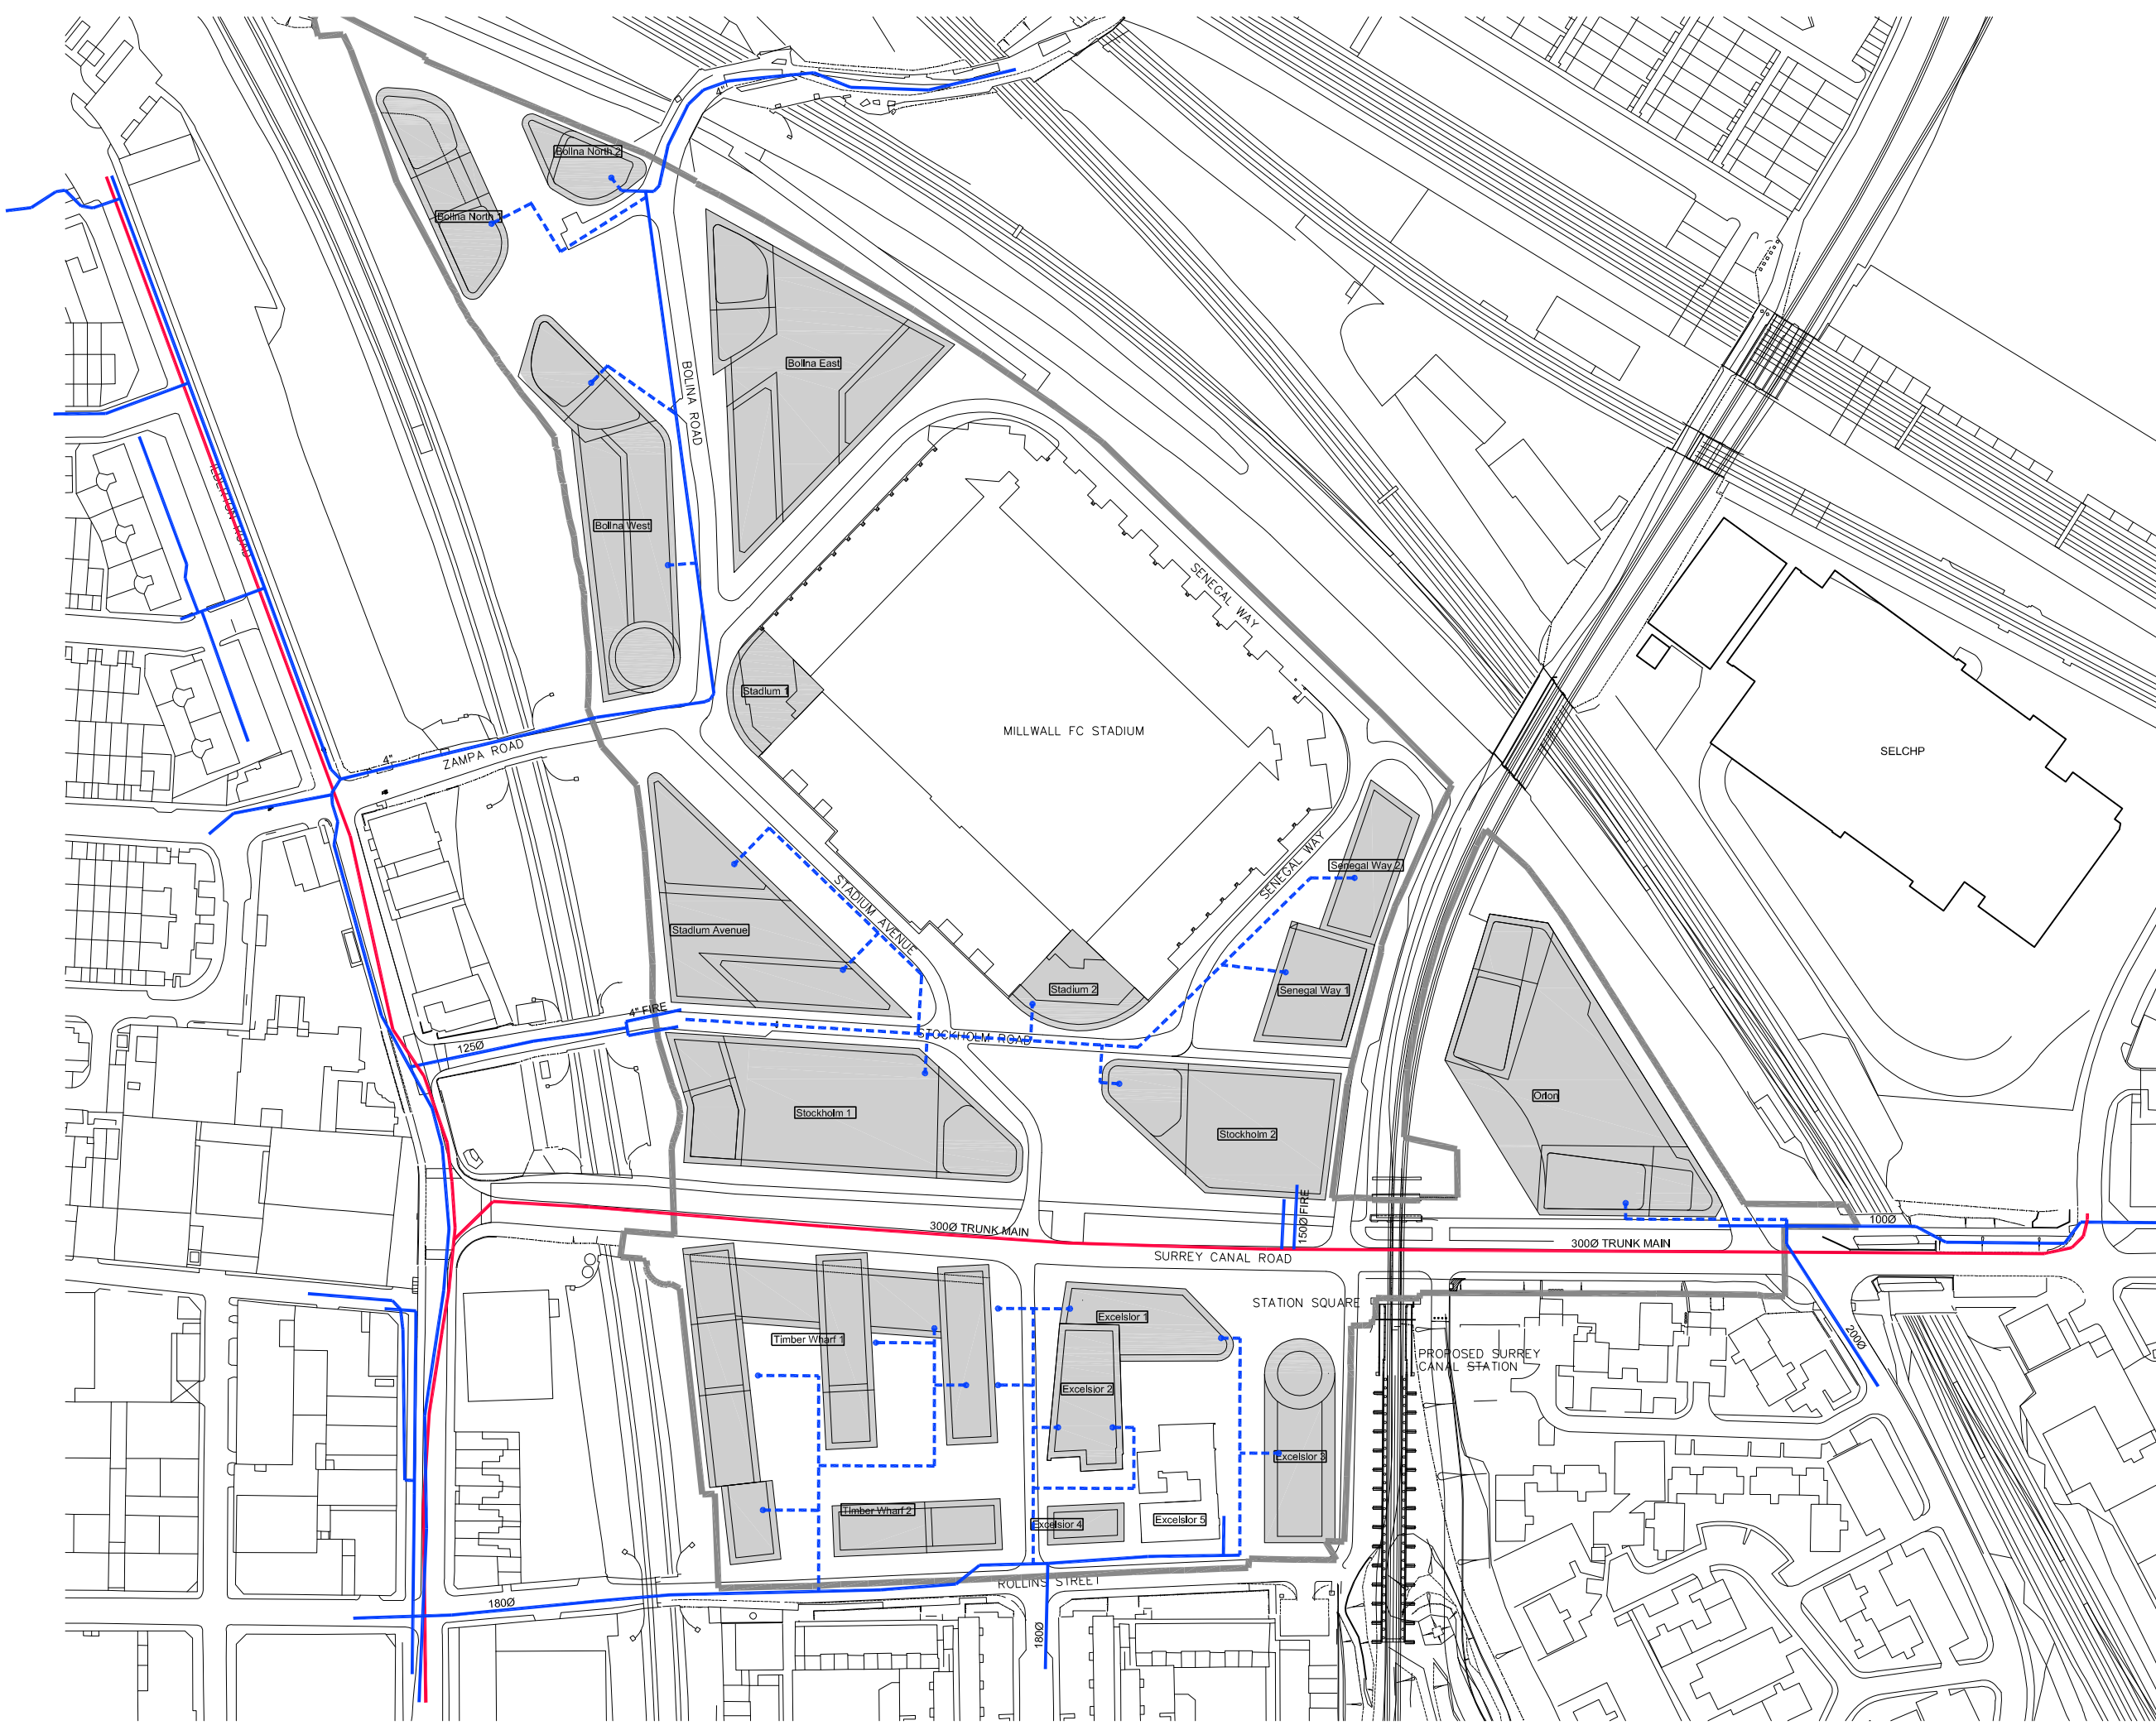

FOR INFORMATION ONLY

Revision	Date	Description	Initials	Checked
01	10.12.10	Issued for Information.	CJA	KWH
00	24.11.10	Issued for Information.	CJA	KWH



HILSON MORAN • CONSULTING ENGINEERS

Farnborough: T: +44(0) 1252 550 500 F: +44(0) 1252 550 501
 London: T: +44(0) 20 7940 8888 F: +44(0) 20 7940 8801
 Manchester: T: +44(0) 161 576 4990 F: +44(0) 161 577 4389

Architect
SEW
 1 Compton Courtyard
 40 Compton Street
 London EC1V 0AP
 Client/Project

Renewal
 Surrey Canal

Title
Proposed Site Plan
Proposed Water Distribution

Drawn	Checked	Approved
CJA	KWH	-

Date: October 2010 Sheet Size: A0 Scale: 1:1000